



Yergensen, Obering, & Whittaker  
A Professional Corporation  
Architecture & Planning  
115 S. Weber Colorado Springs, Colorado 719-475-8133

Structural: MGA  
Electrical: ENGS  
Mechanical: ENGS  
Civil: ENGS  
Plumbing: PENS

Revision Schedule  
No. Date


Calvary Fellowship - Fountain Valley  
Suite 7R - PHASE I  
6436 South Highway 85-87  
Fountain, Colorado 80817

Project Number  
08.012  
Date  
9-22-08  
Drawn By  
Author  
Checked By  
Checker

A102  
Floor Plan - North  
Scale  
1/8" = 1'-0"

10/3/2008 1:07:45 PM

1 Floor Plan - North  
1/8" = 1'-0"

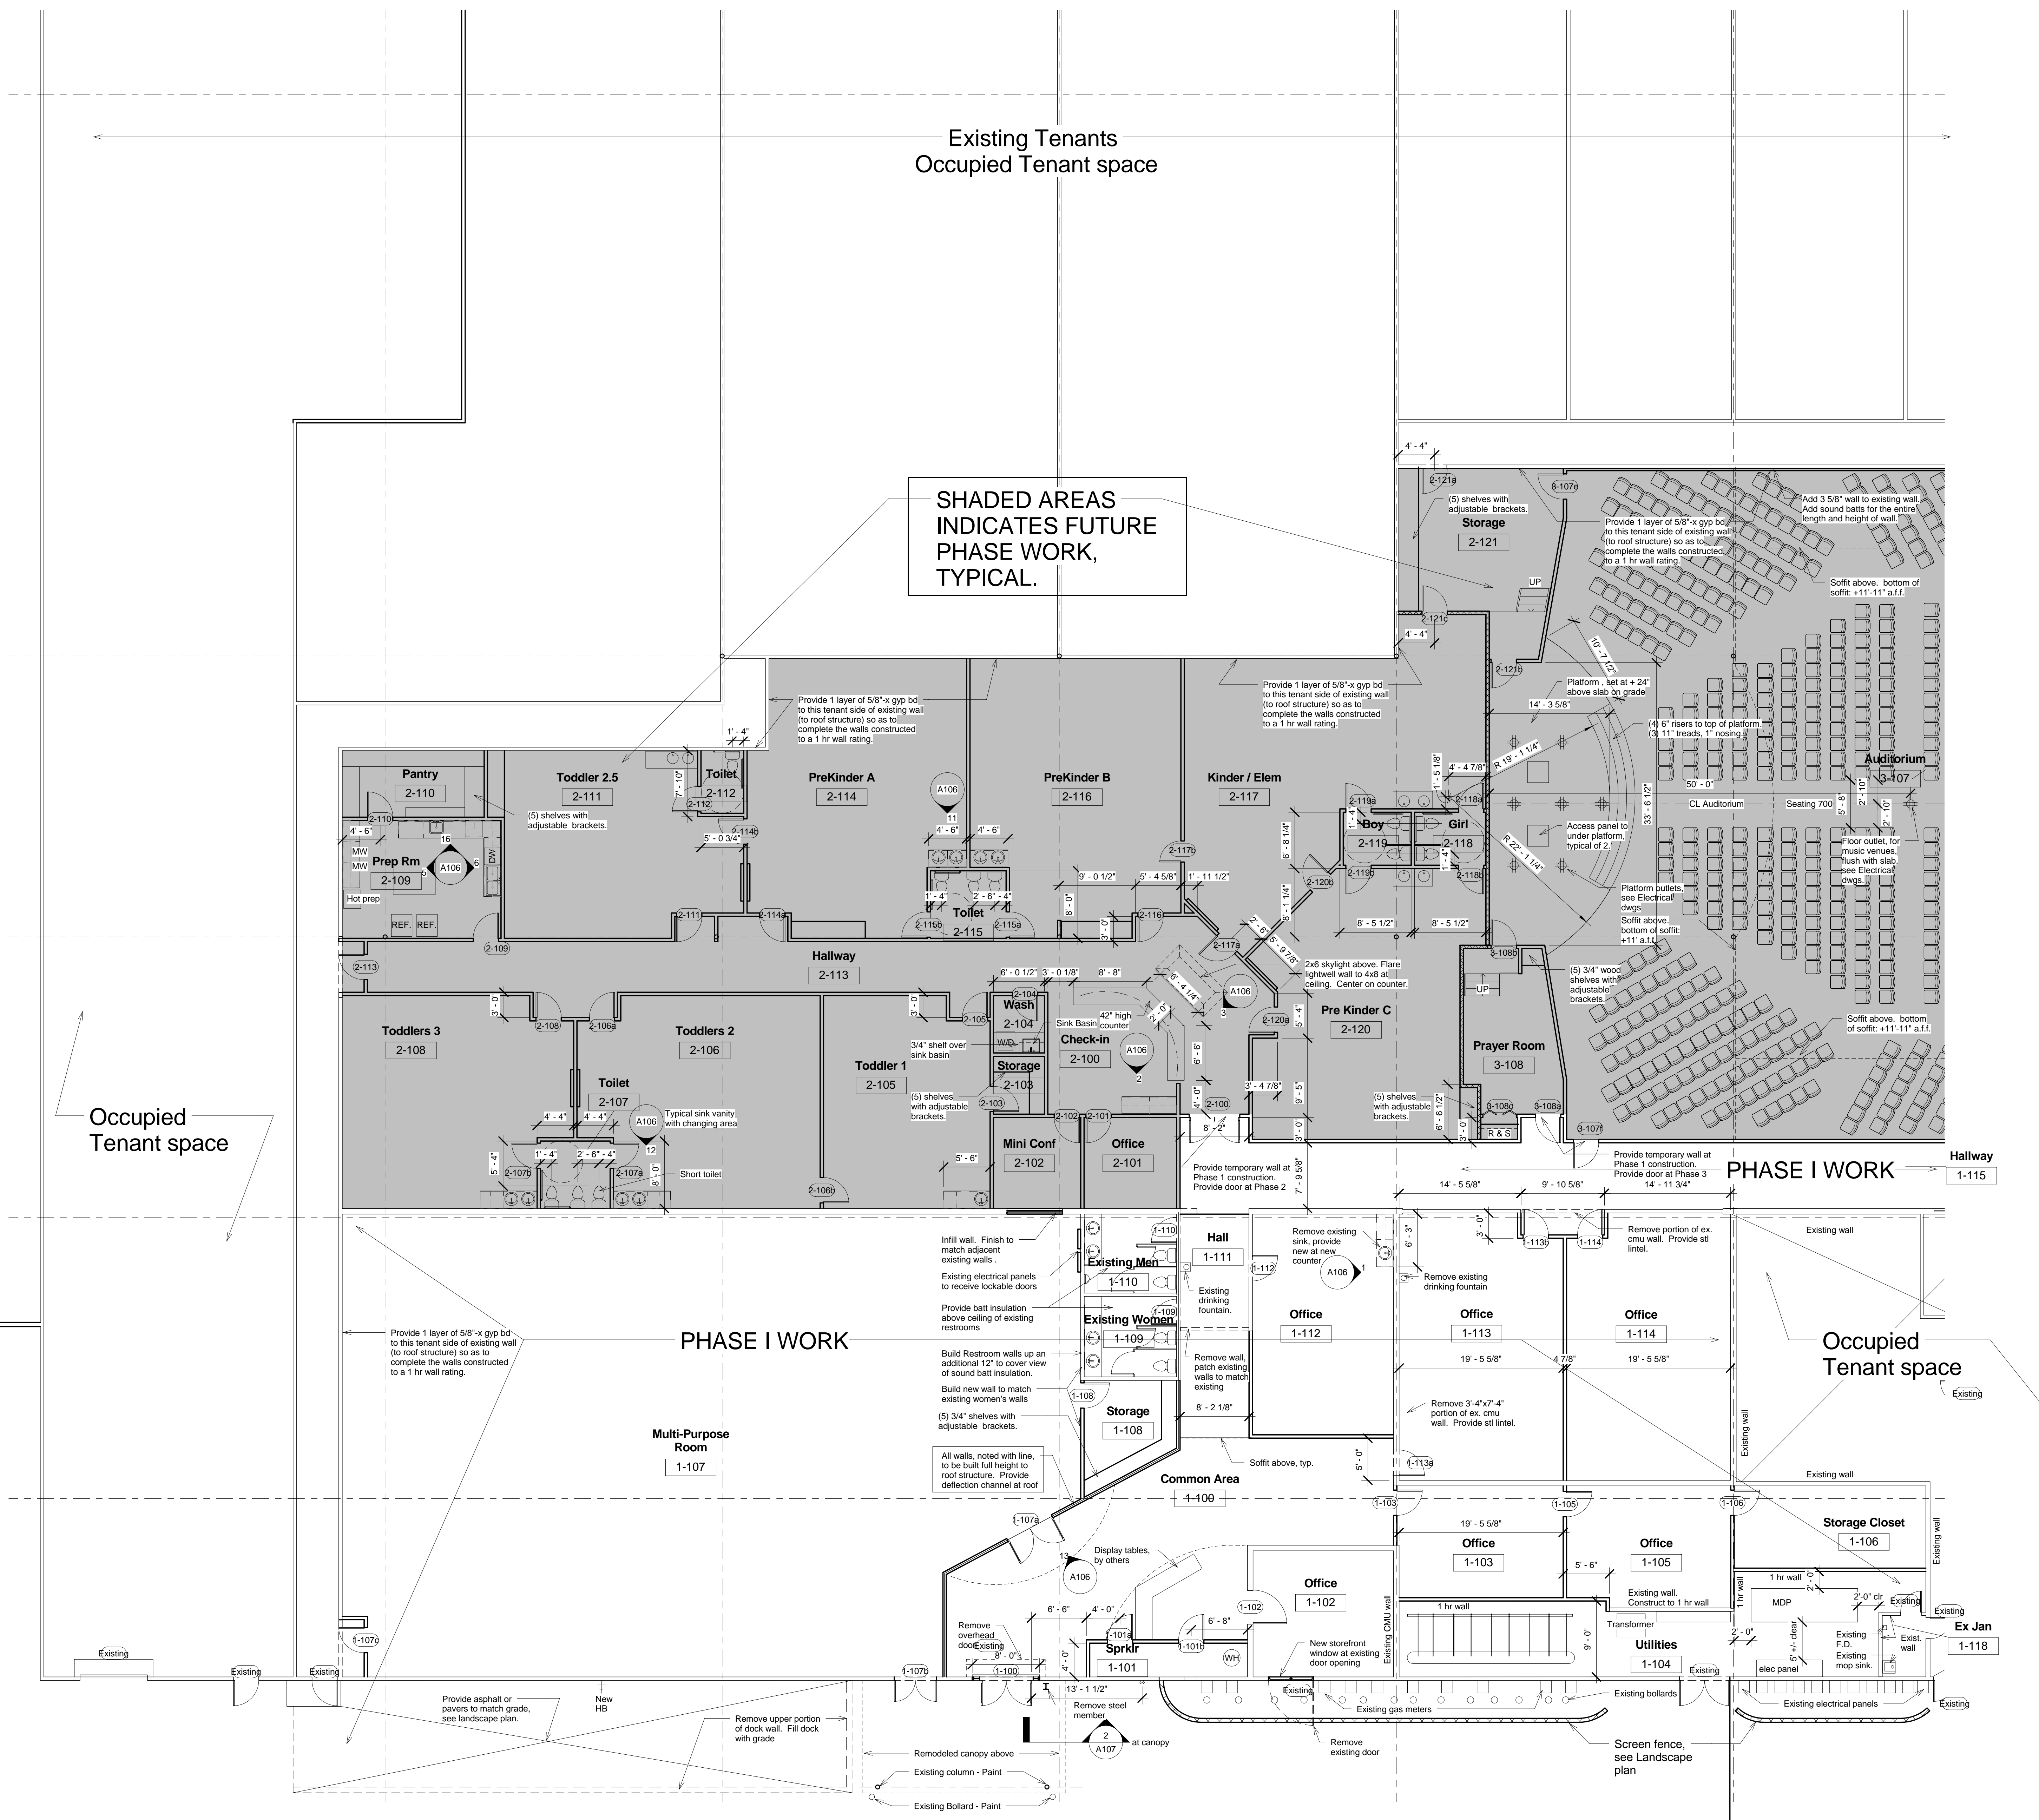

SHADED AREAS INDICATE FUTURE PHASE WORK, TYPICAL.

Occupied Tenant space

Occupied Tenant space

PHASE I WORK

PHASE I WORK