



Yergensen, Obering, & Whittaker
A Professional Corporation
Architecture & Planning
115 S. Weber Colorado Springs, Colorado 719-475-8133

Structural: MGA
Electrical: ENG3
Mechanical: ENG3
Civil: ENG3
PENG3

Revision Schedule

No. Date


Calvary Fellowship - Fountain Valley
Suite "R" - PHASE I
6436 South Highway 85-87
Fountain, Colorado 80817

Project Number
08.012


Date
9-22-08

Drawn By
Author
Checked By
Checker

A103
Floor Plan South
Scale
As indicated

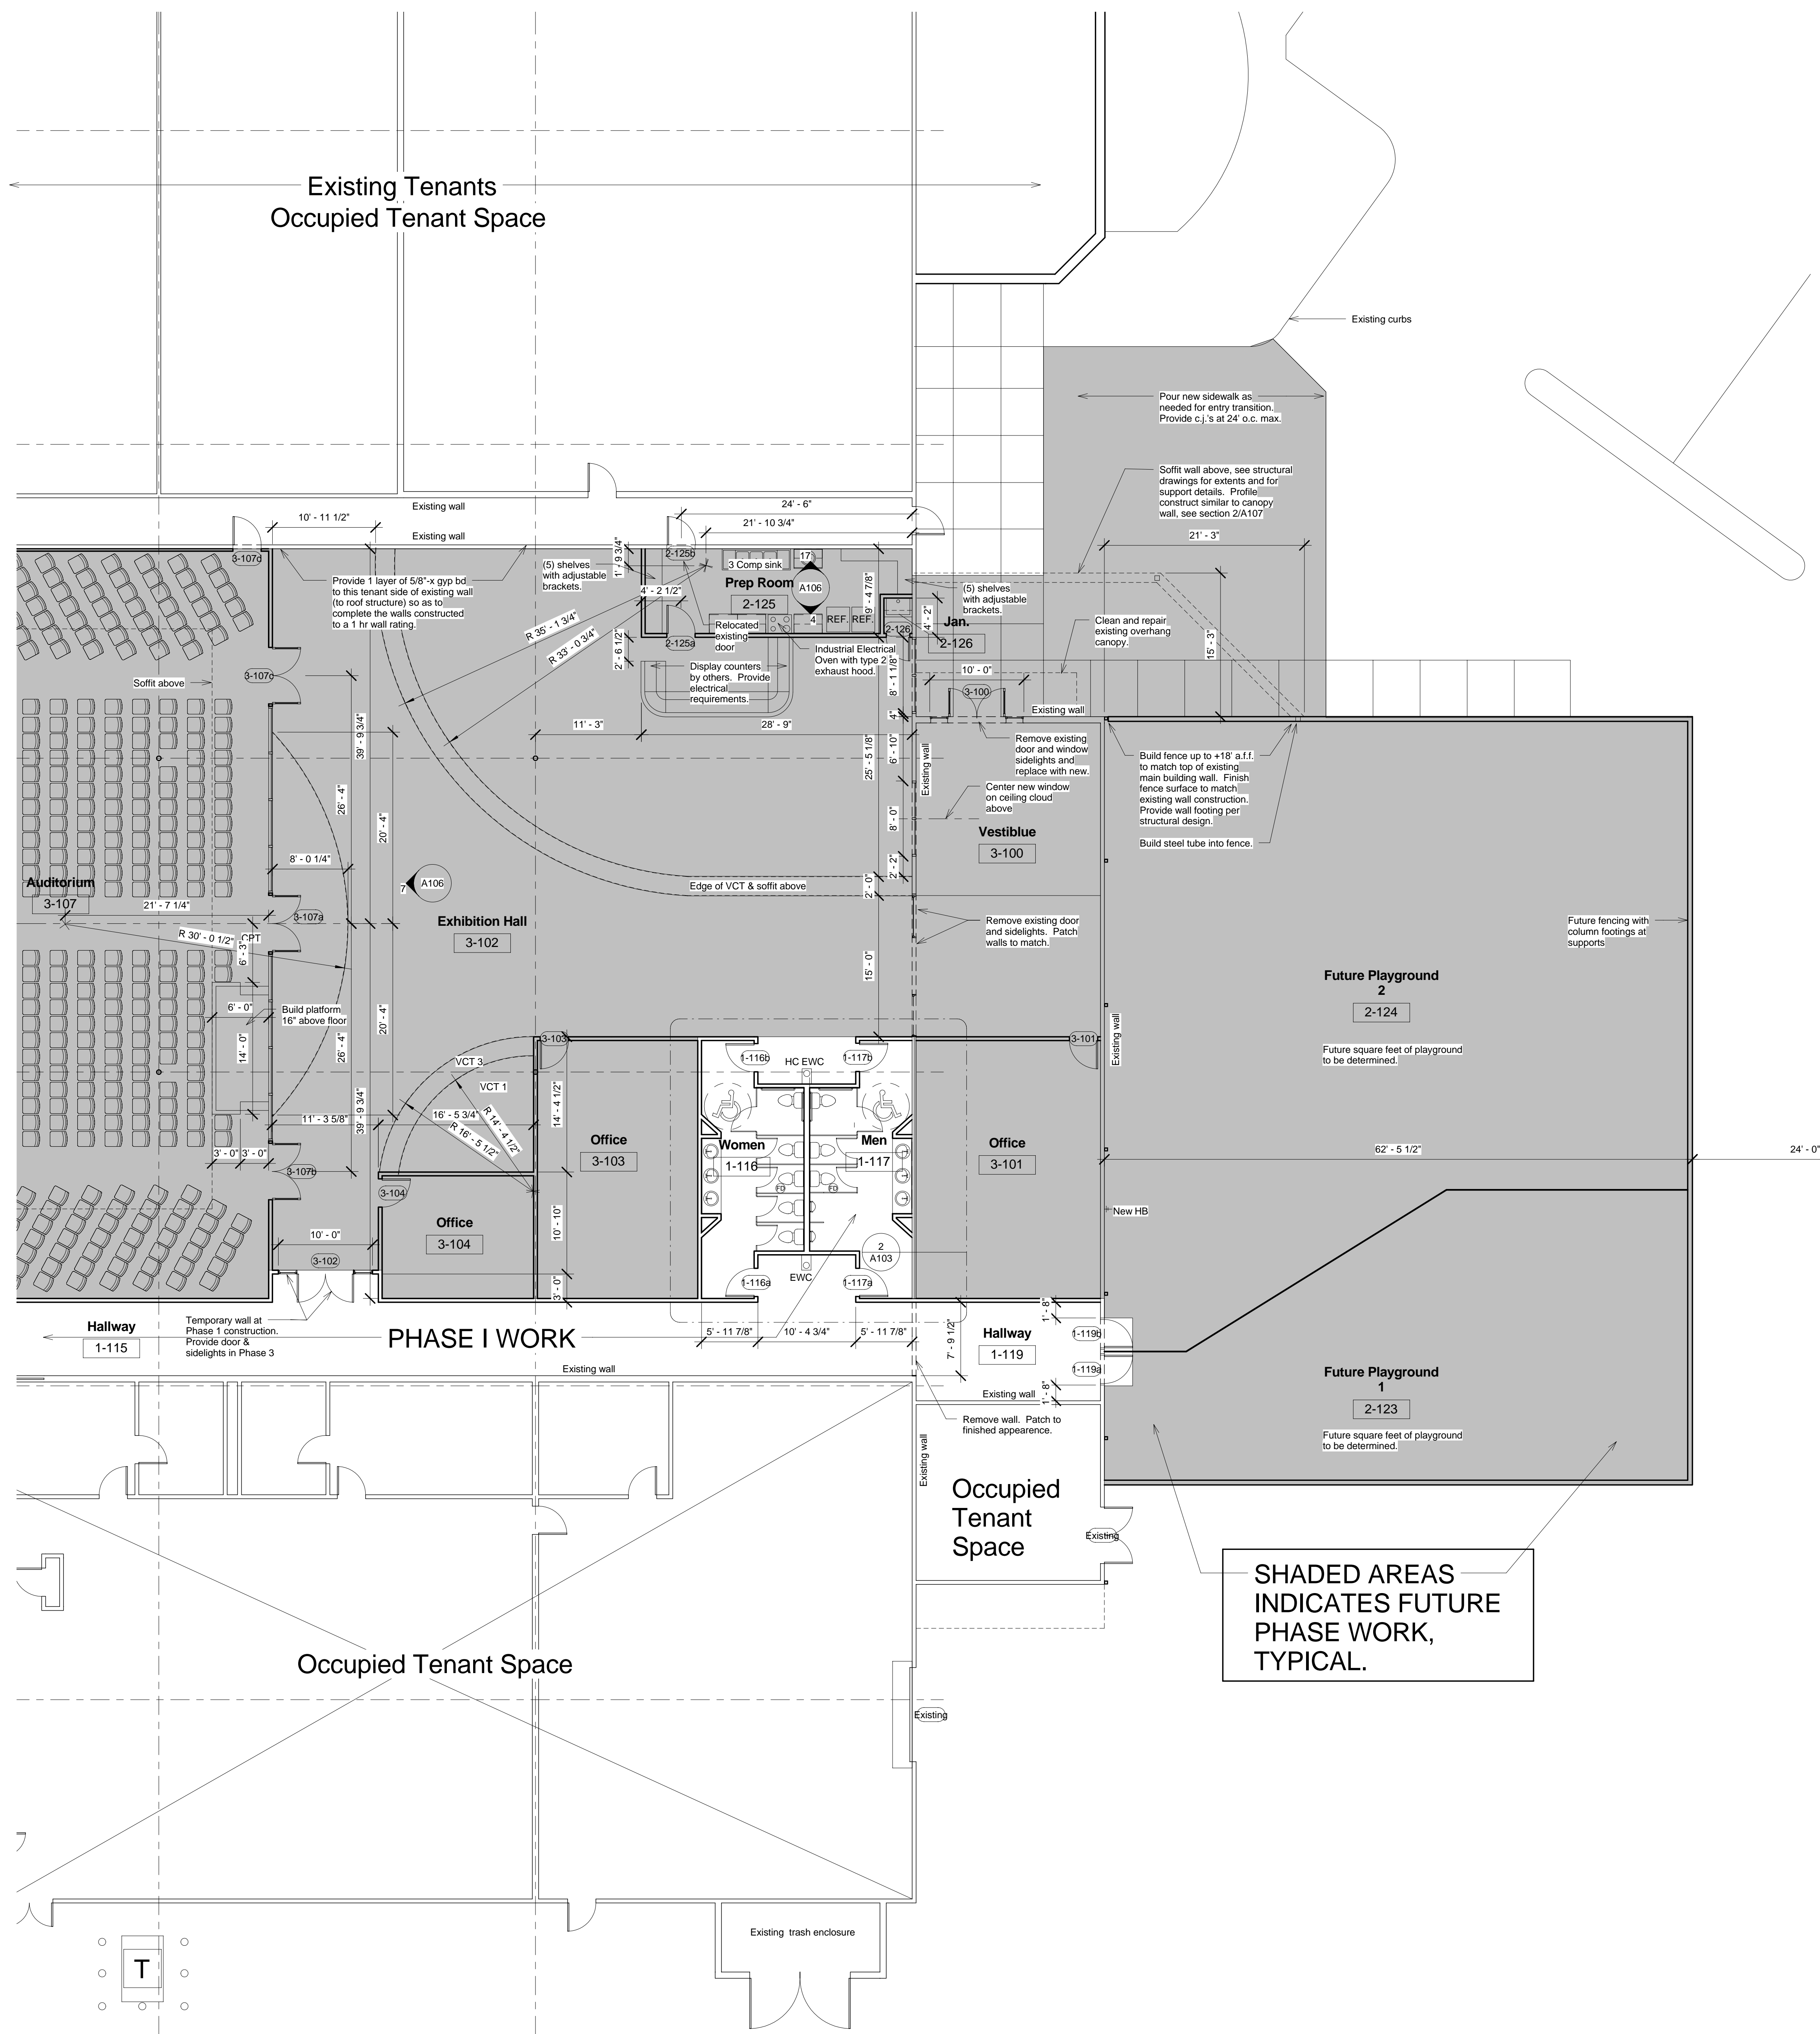

SHADED AREAS
INDICATES FUTURE
PHASE WORK,
TYPICAL.

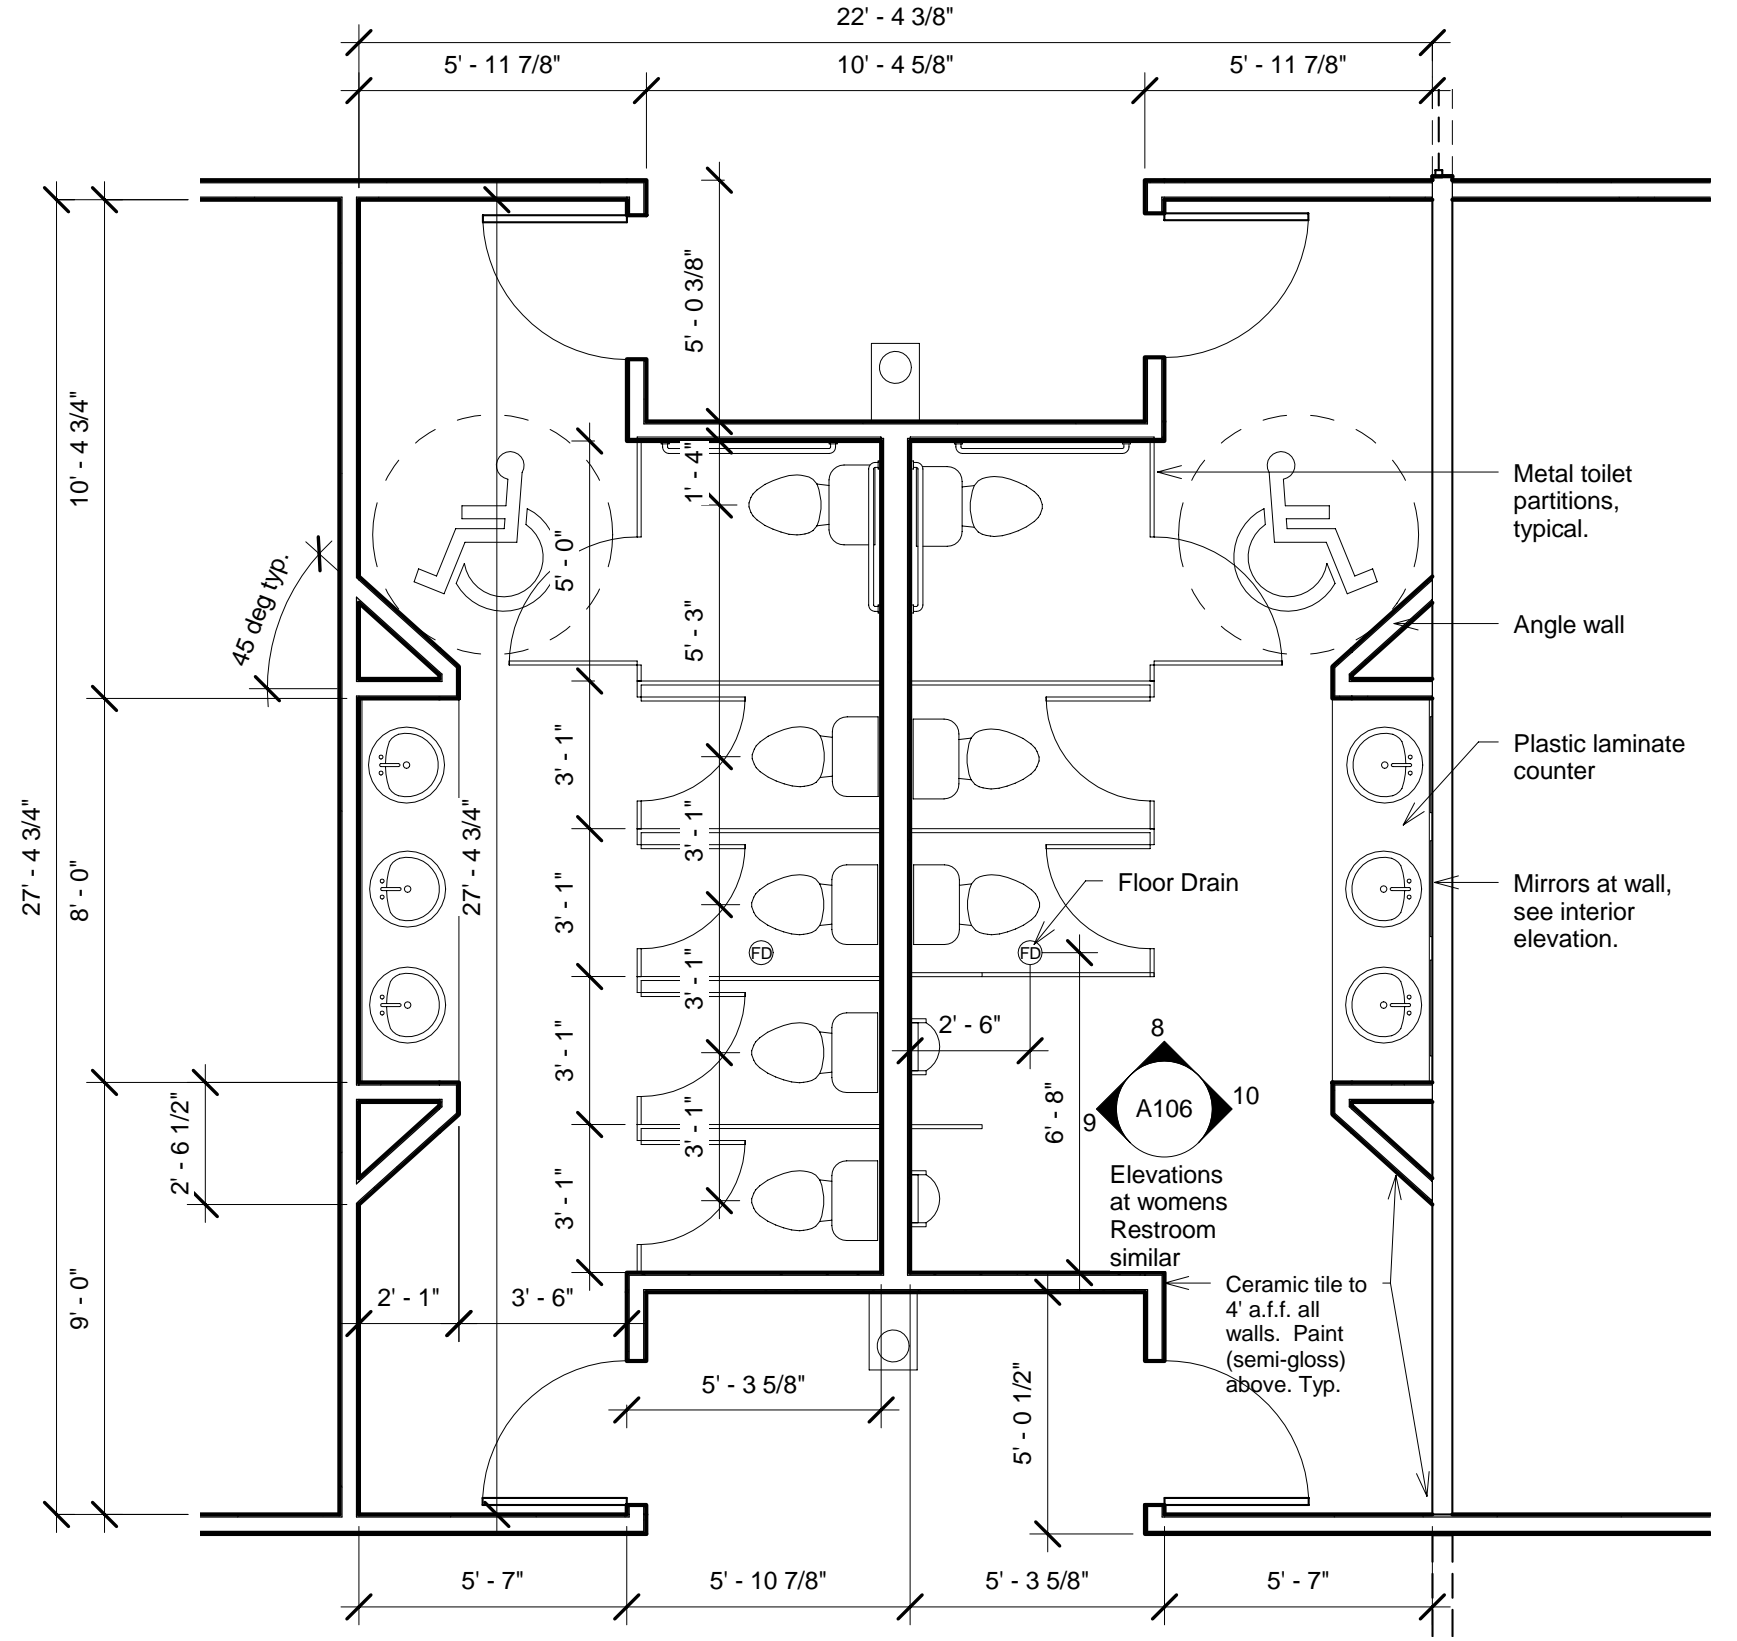

2 Enlarged Restroom Plan
1/4" = 1'-0"

1 Floor Plan - South
1/8" = 1'-0"