



YOW ARCHITECTS INC.  
Architecture & Planning  
115 S. Weber Colorado Springs, Colorado 719-475-8133

Structural: MGA  
Electrical: ENGS  
Mechanical: ENGS  
Plumbing: ENGS

Revision Schedule  
No. Date Rev

Calvary Fellowship - Fountain Valley  
Suite 7R - PHASE I  
6436 South Highway 85-87  
Fountain, Colorado 80817

Project Number  
08.012

Date  
09/22/08

Drawn By  
Author  
Checked By  
Checker


A104  
RCP North  
Scale  
1/8" = 1'-0"

Existing occupied space  
Occupied Tenant space

SHADED AREAS INDICATES FUTURE PHASE WORK, TYPICAL.


Occupied Tenant space

Occupied Tenant space

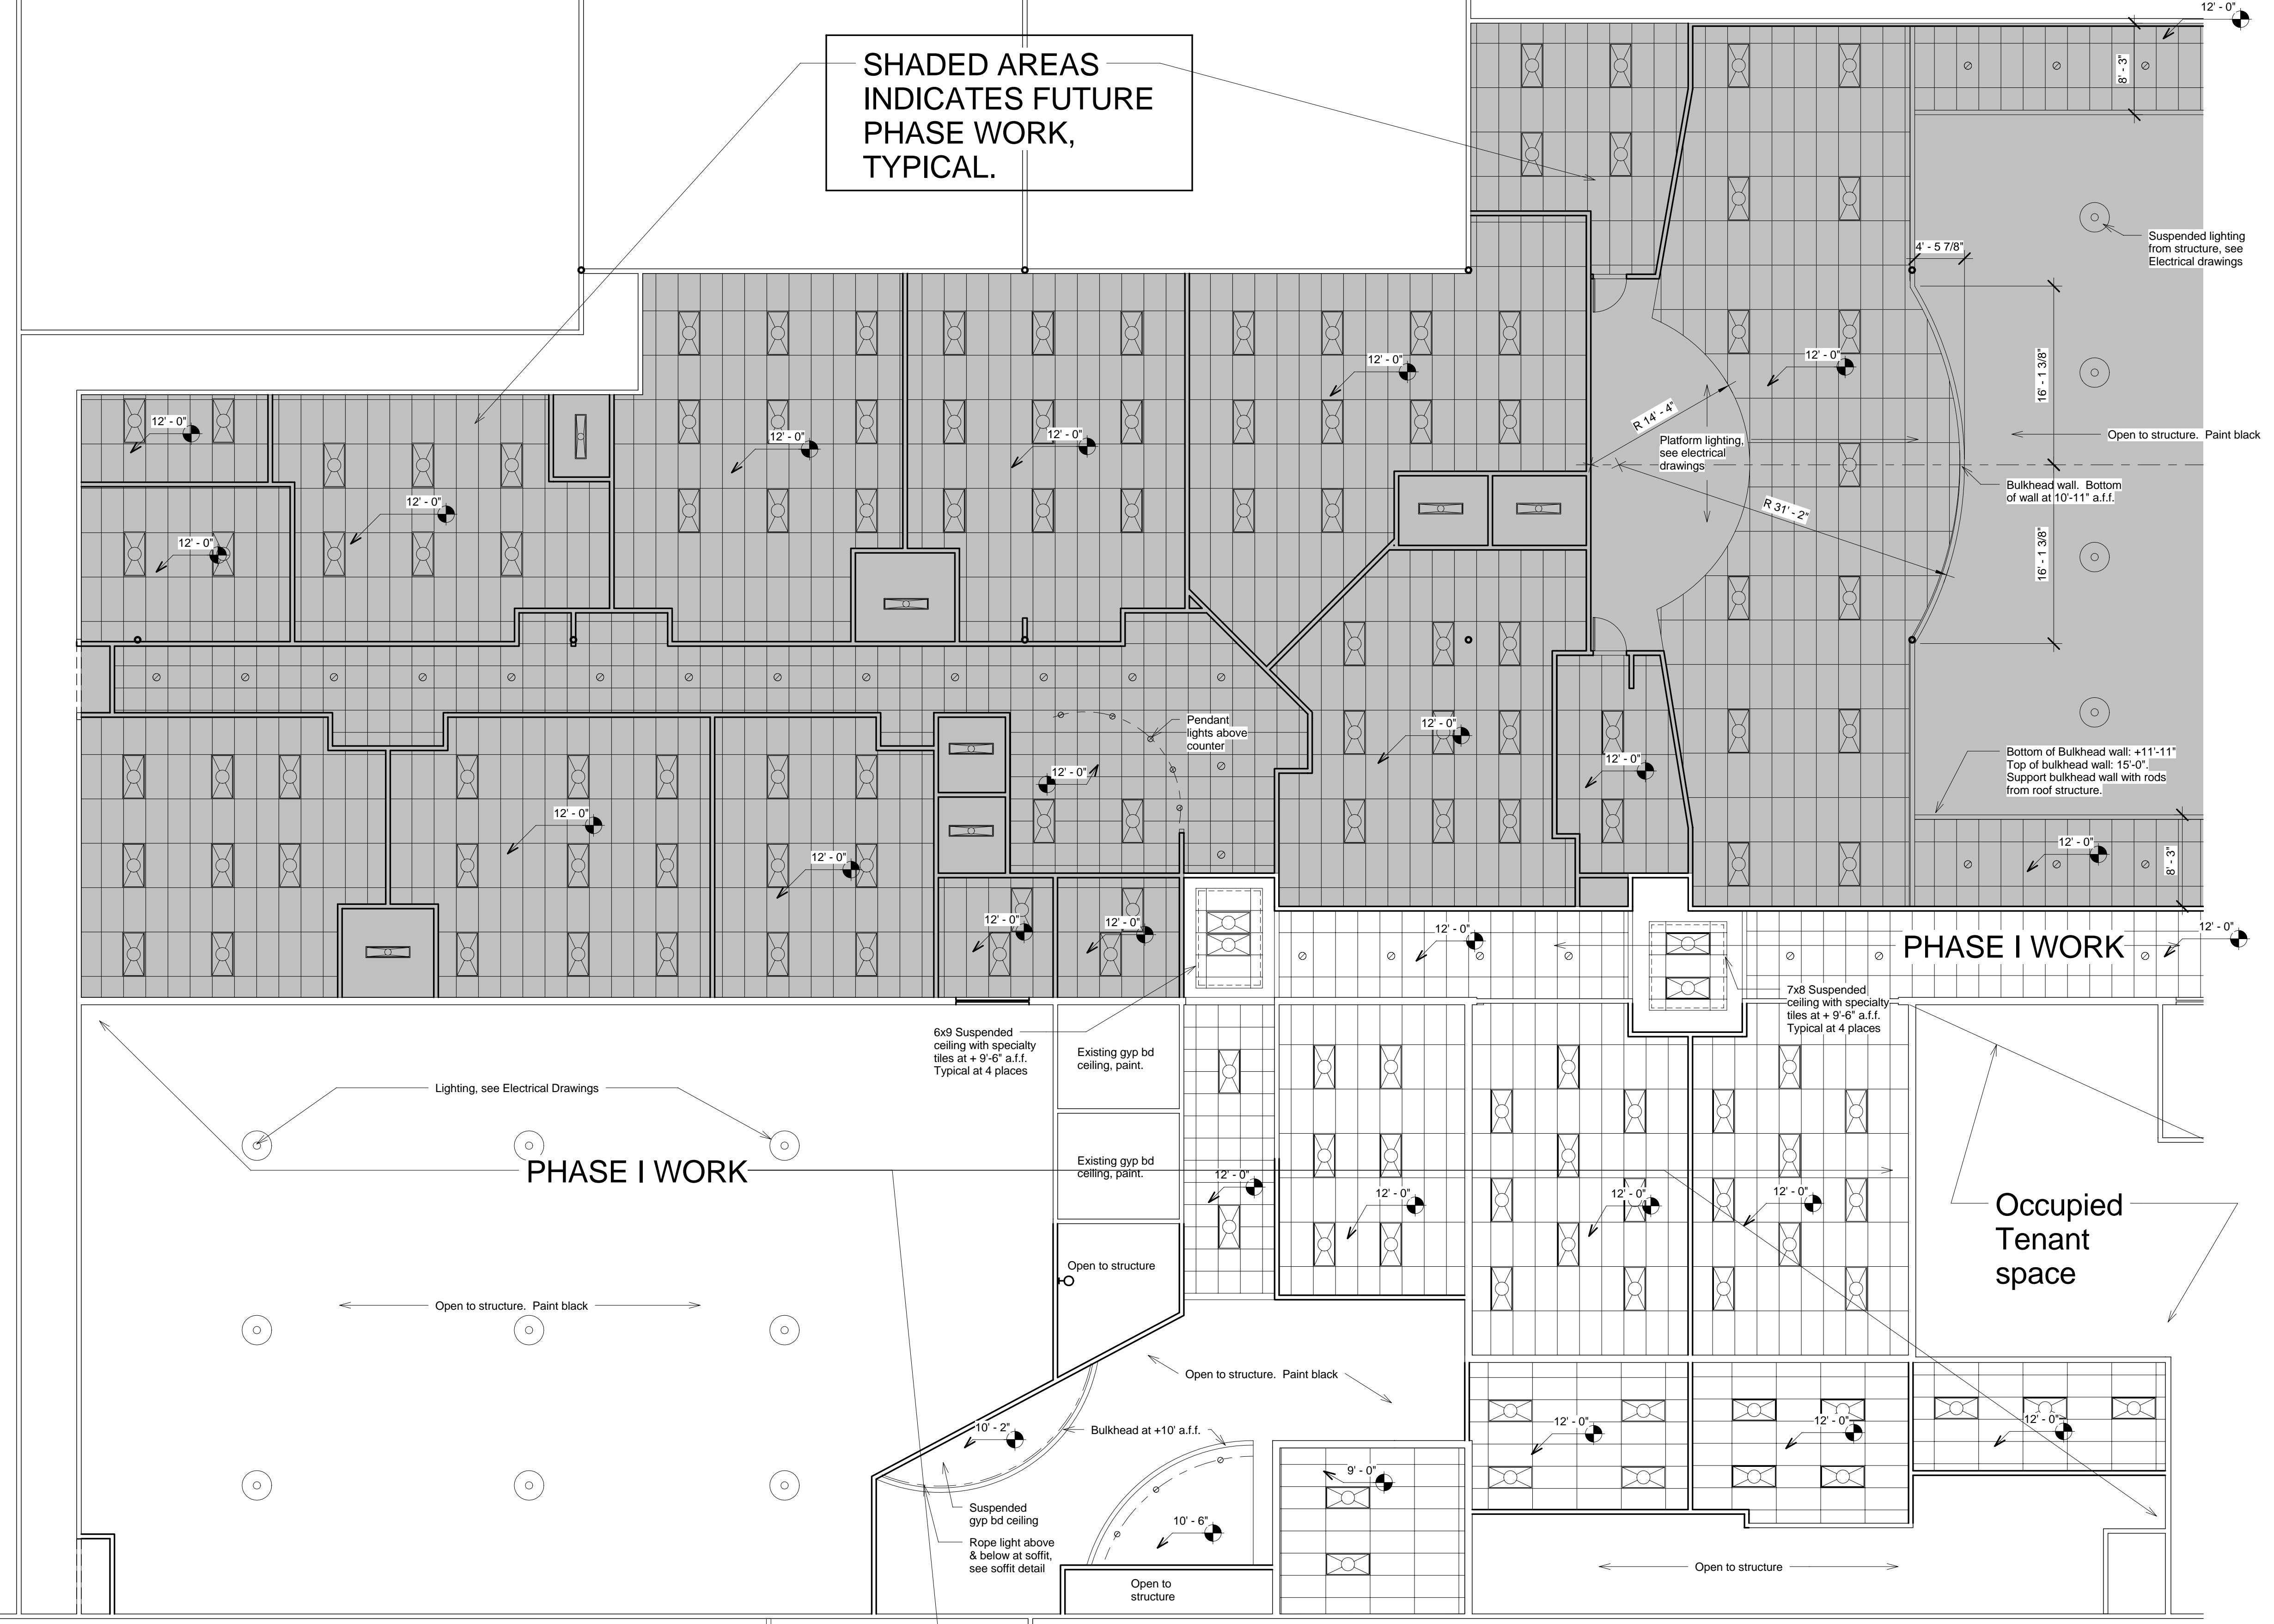

PHASE I WORK

PHASE I WORK

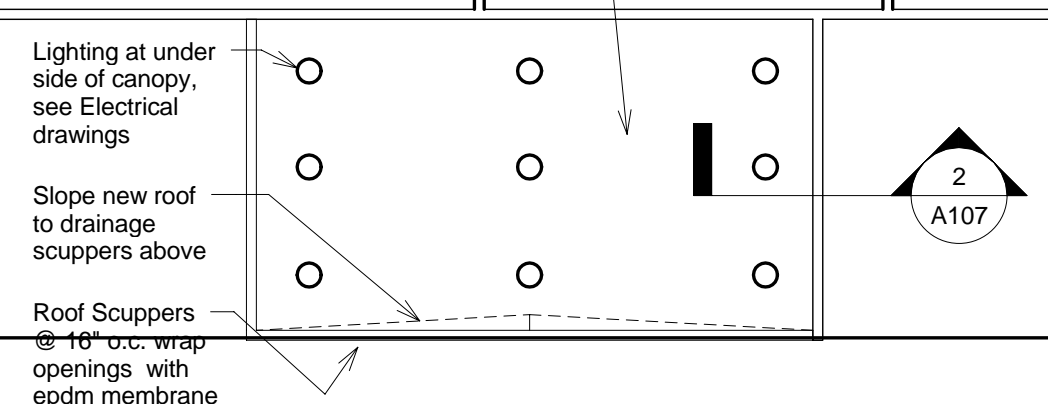

1 Reflected Ceiling Plan - North  
1/8" = 1'-0"