



YOW ARCHITECTS INC.  
Architecture & Planning  
115 S. Weber Colorado Springs, Colorado 719-475-8133

Structural: MGA  
Electrical: ENCS  
Mechanical: ENCS  
Plumbing: ENCS  
PENGCS

Revision Schedule

No. Date Rev


Calvary Fellowship - Fountain Valley  
Suite "R" - PHASE I  
6436 South Highway 85-87  
Fountain, Colorado 80817

Project Number  
08.012

Date  
09/22/08

Drawn By  
Author  
Checked By  
Checker

A105  
RCP South  
Scale  
1/8" = 1'-0"

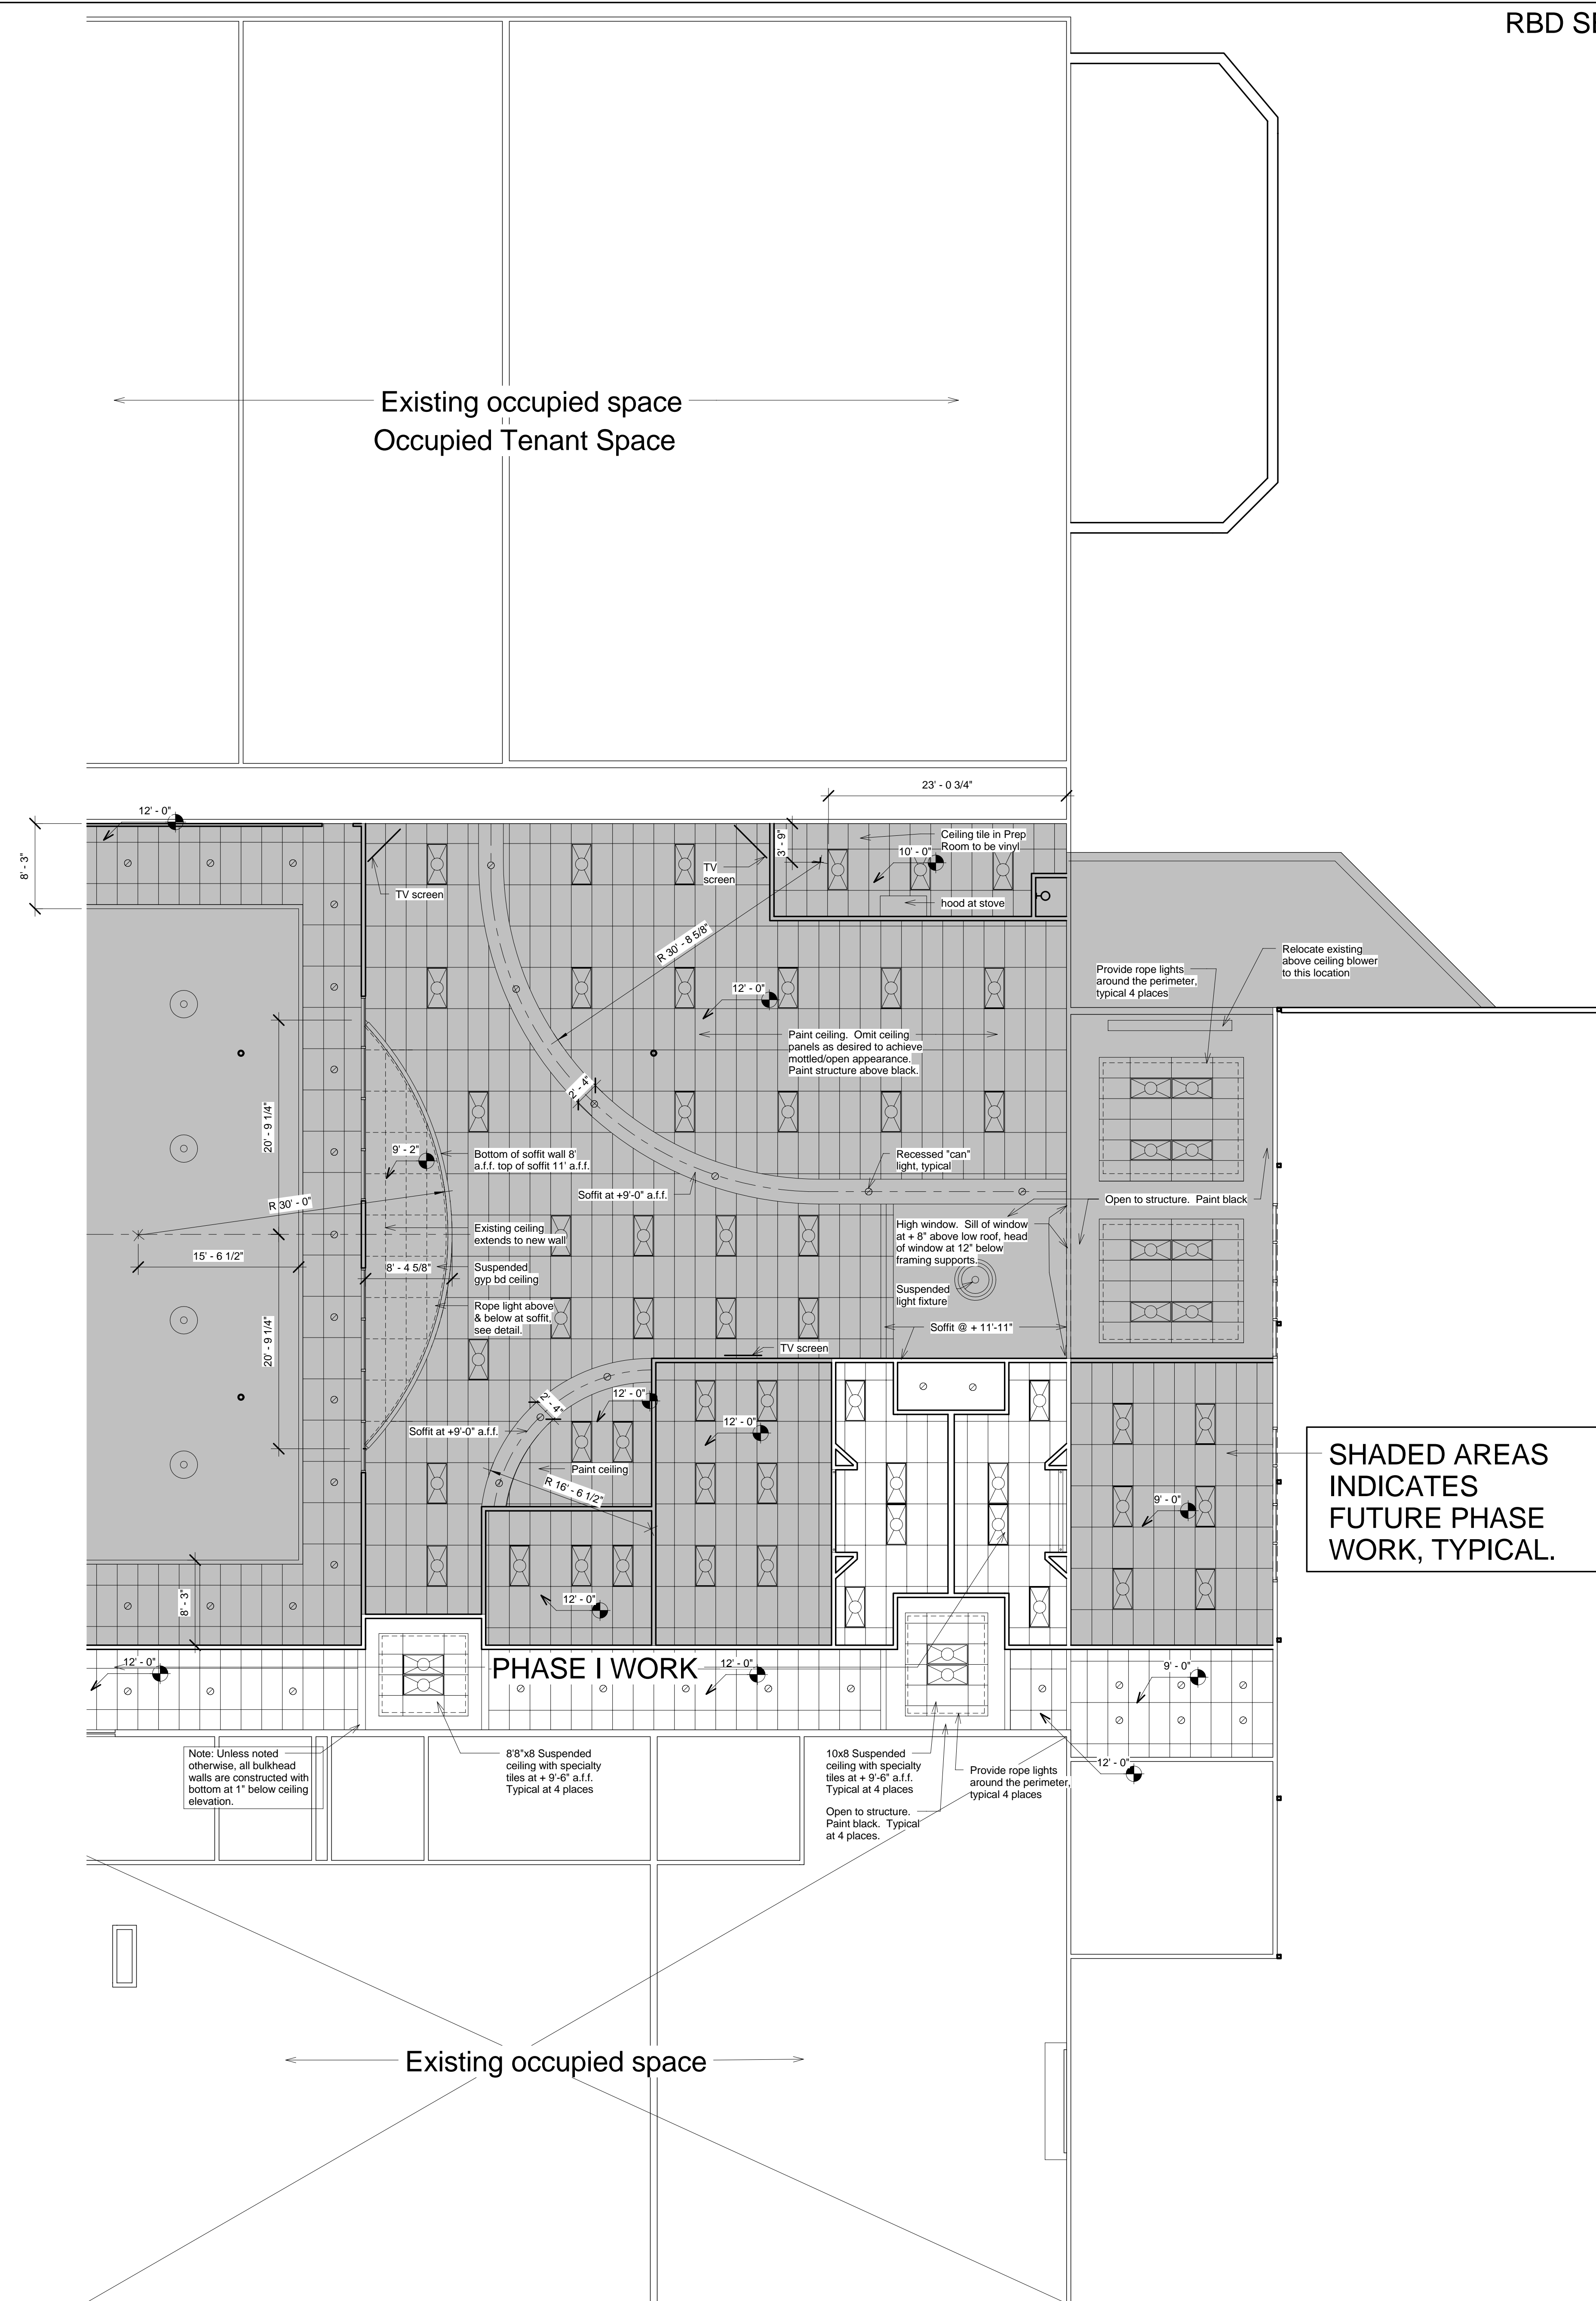

SHADED AREAS INDICATES FUTURE PHASE WORK, TYPICAL.

1 Reflected Ceiling Plan - South  
1/8" = 1'-0"